





Floor 3 Domestic Water Part Layout
1 : 50

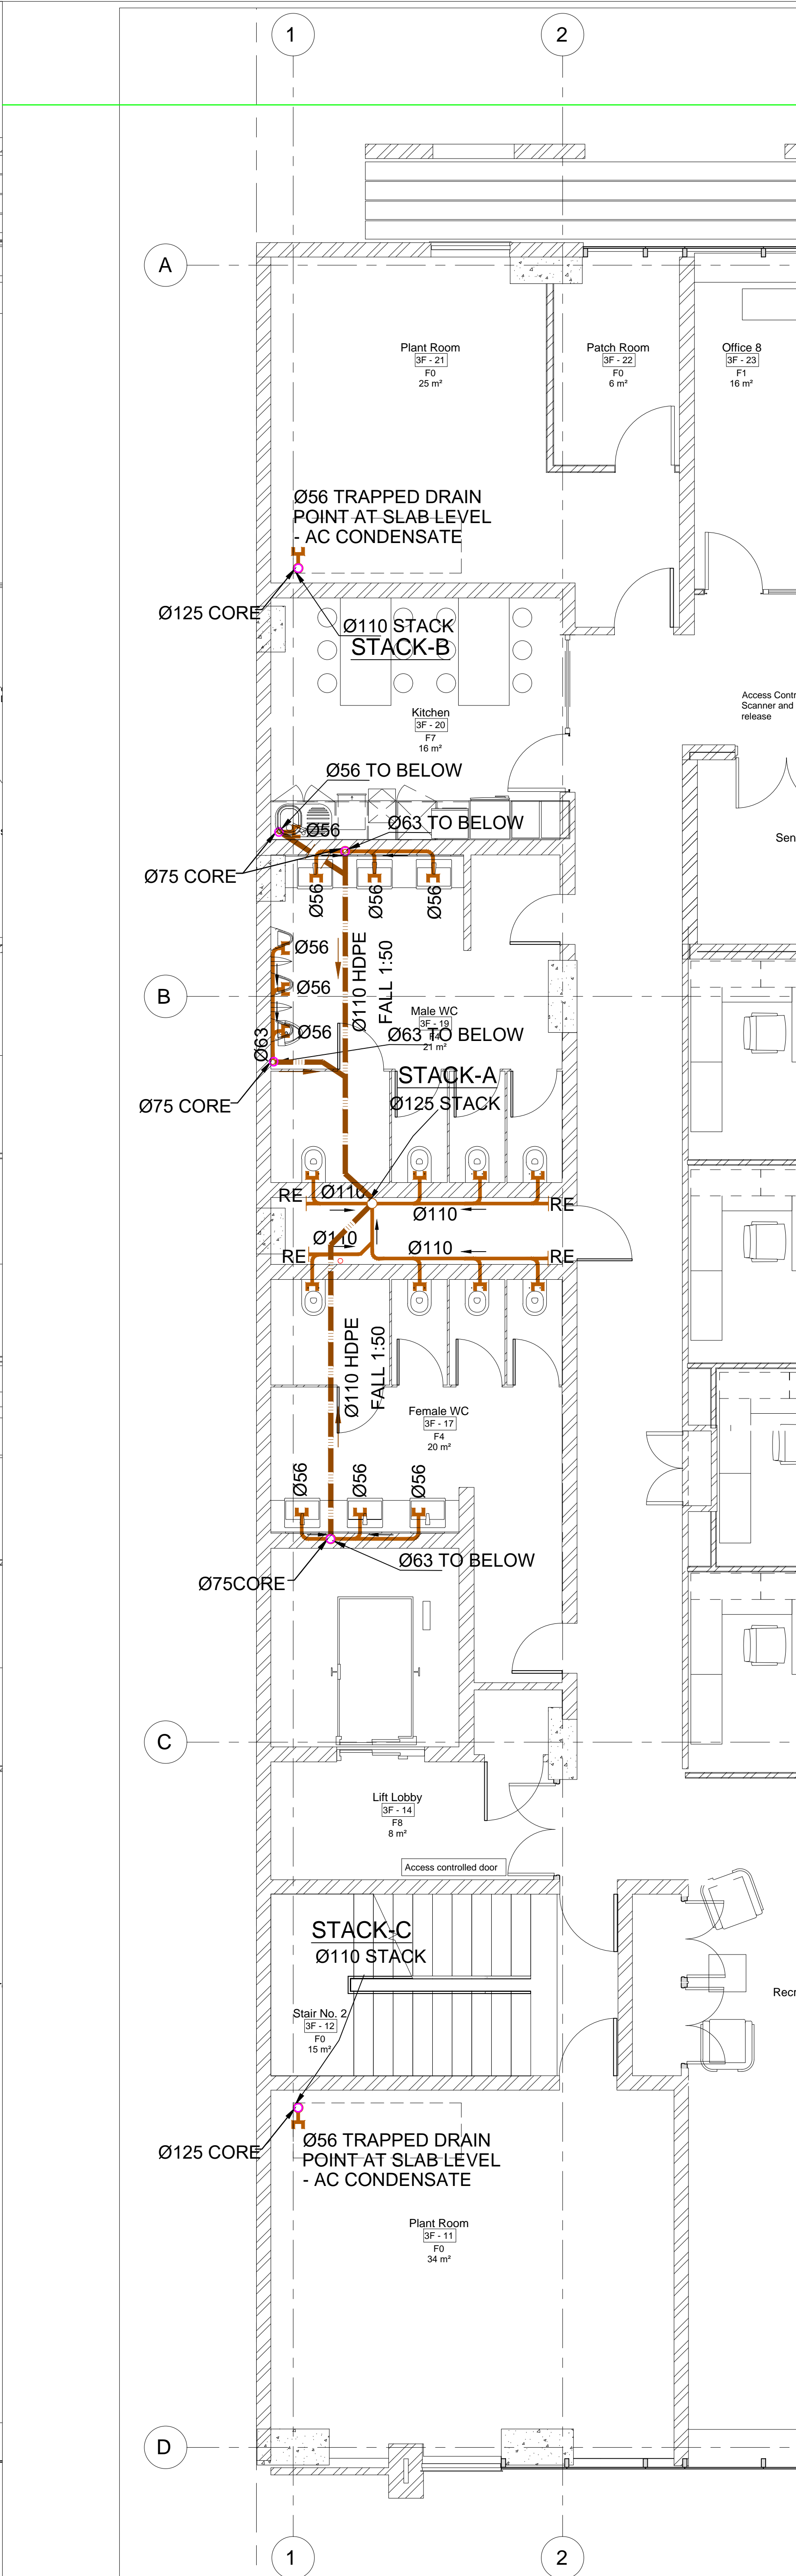

Floor 3 Drainage Part Layout
1 : 50

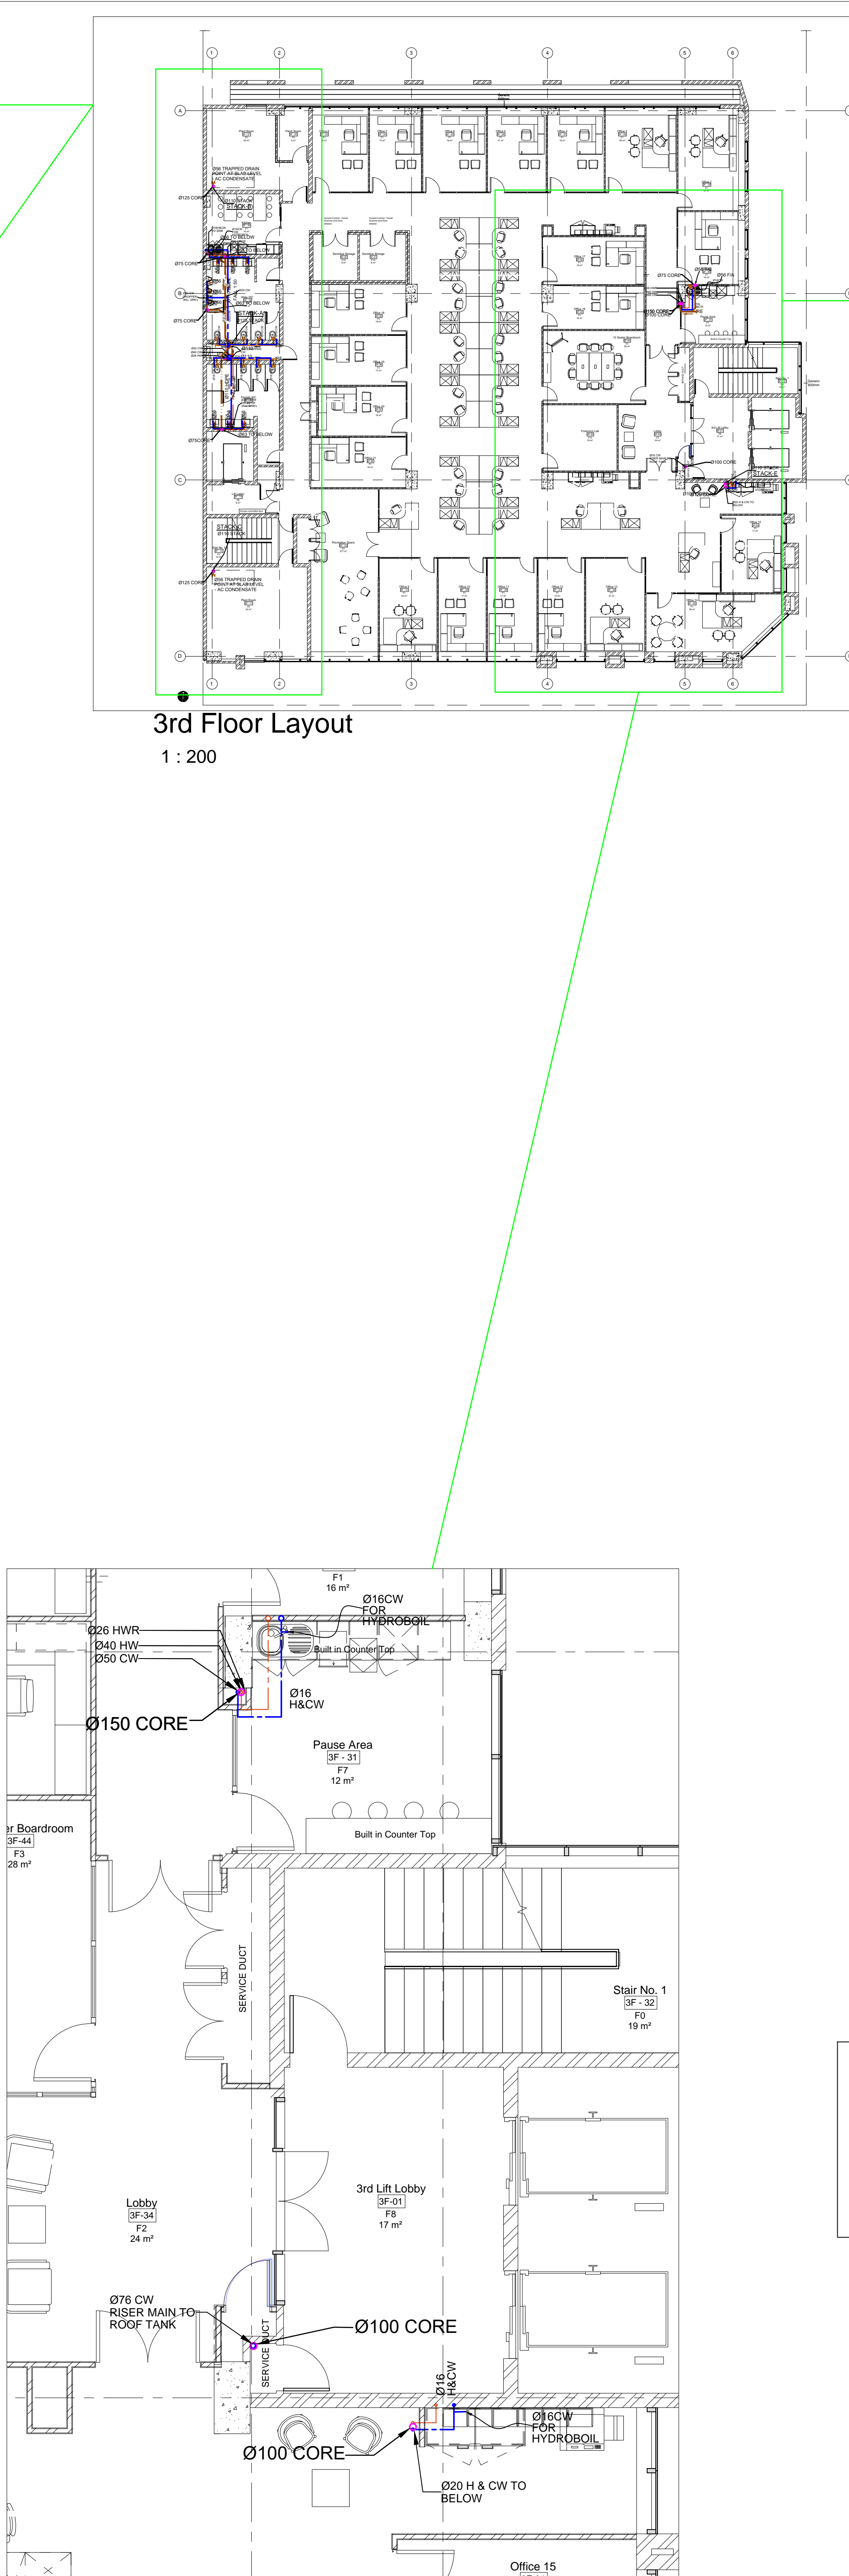

Floor 3 Domestic Water Part Layout
1 : 50

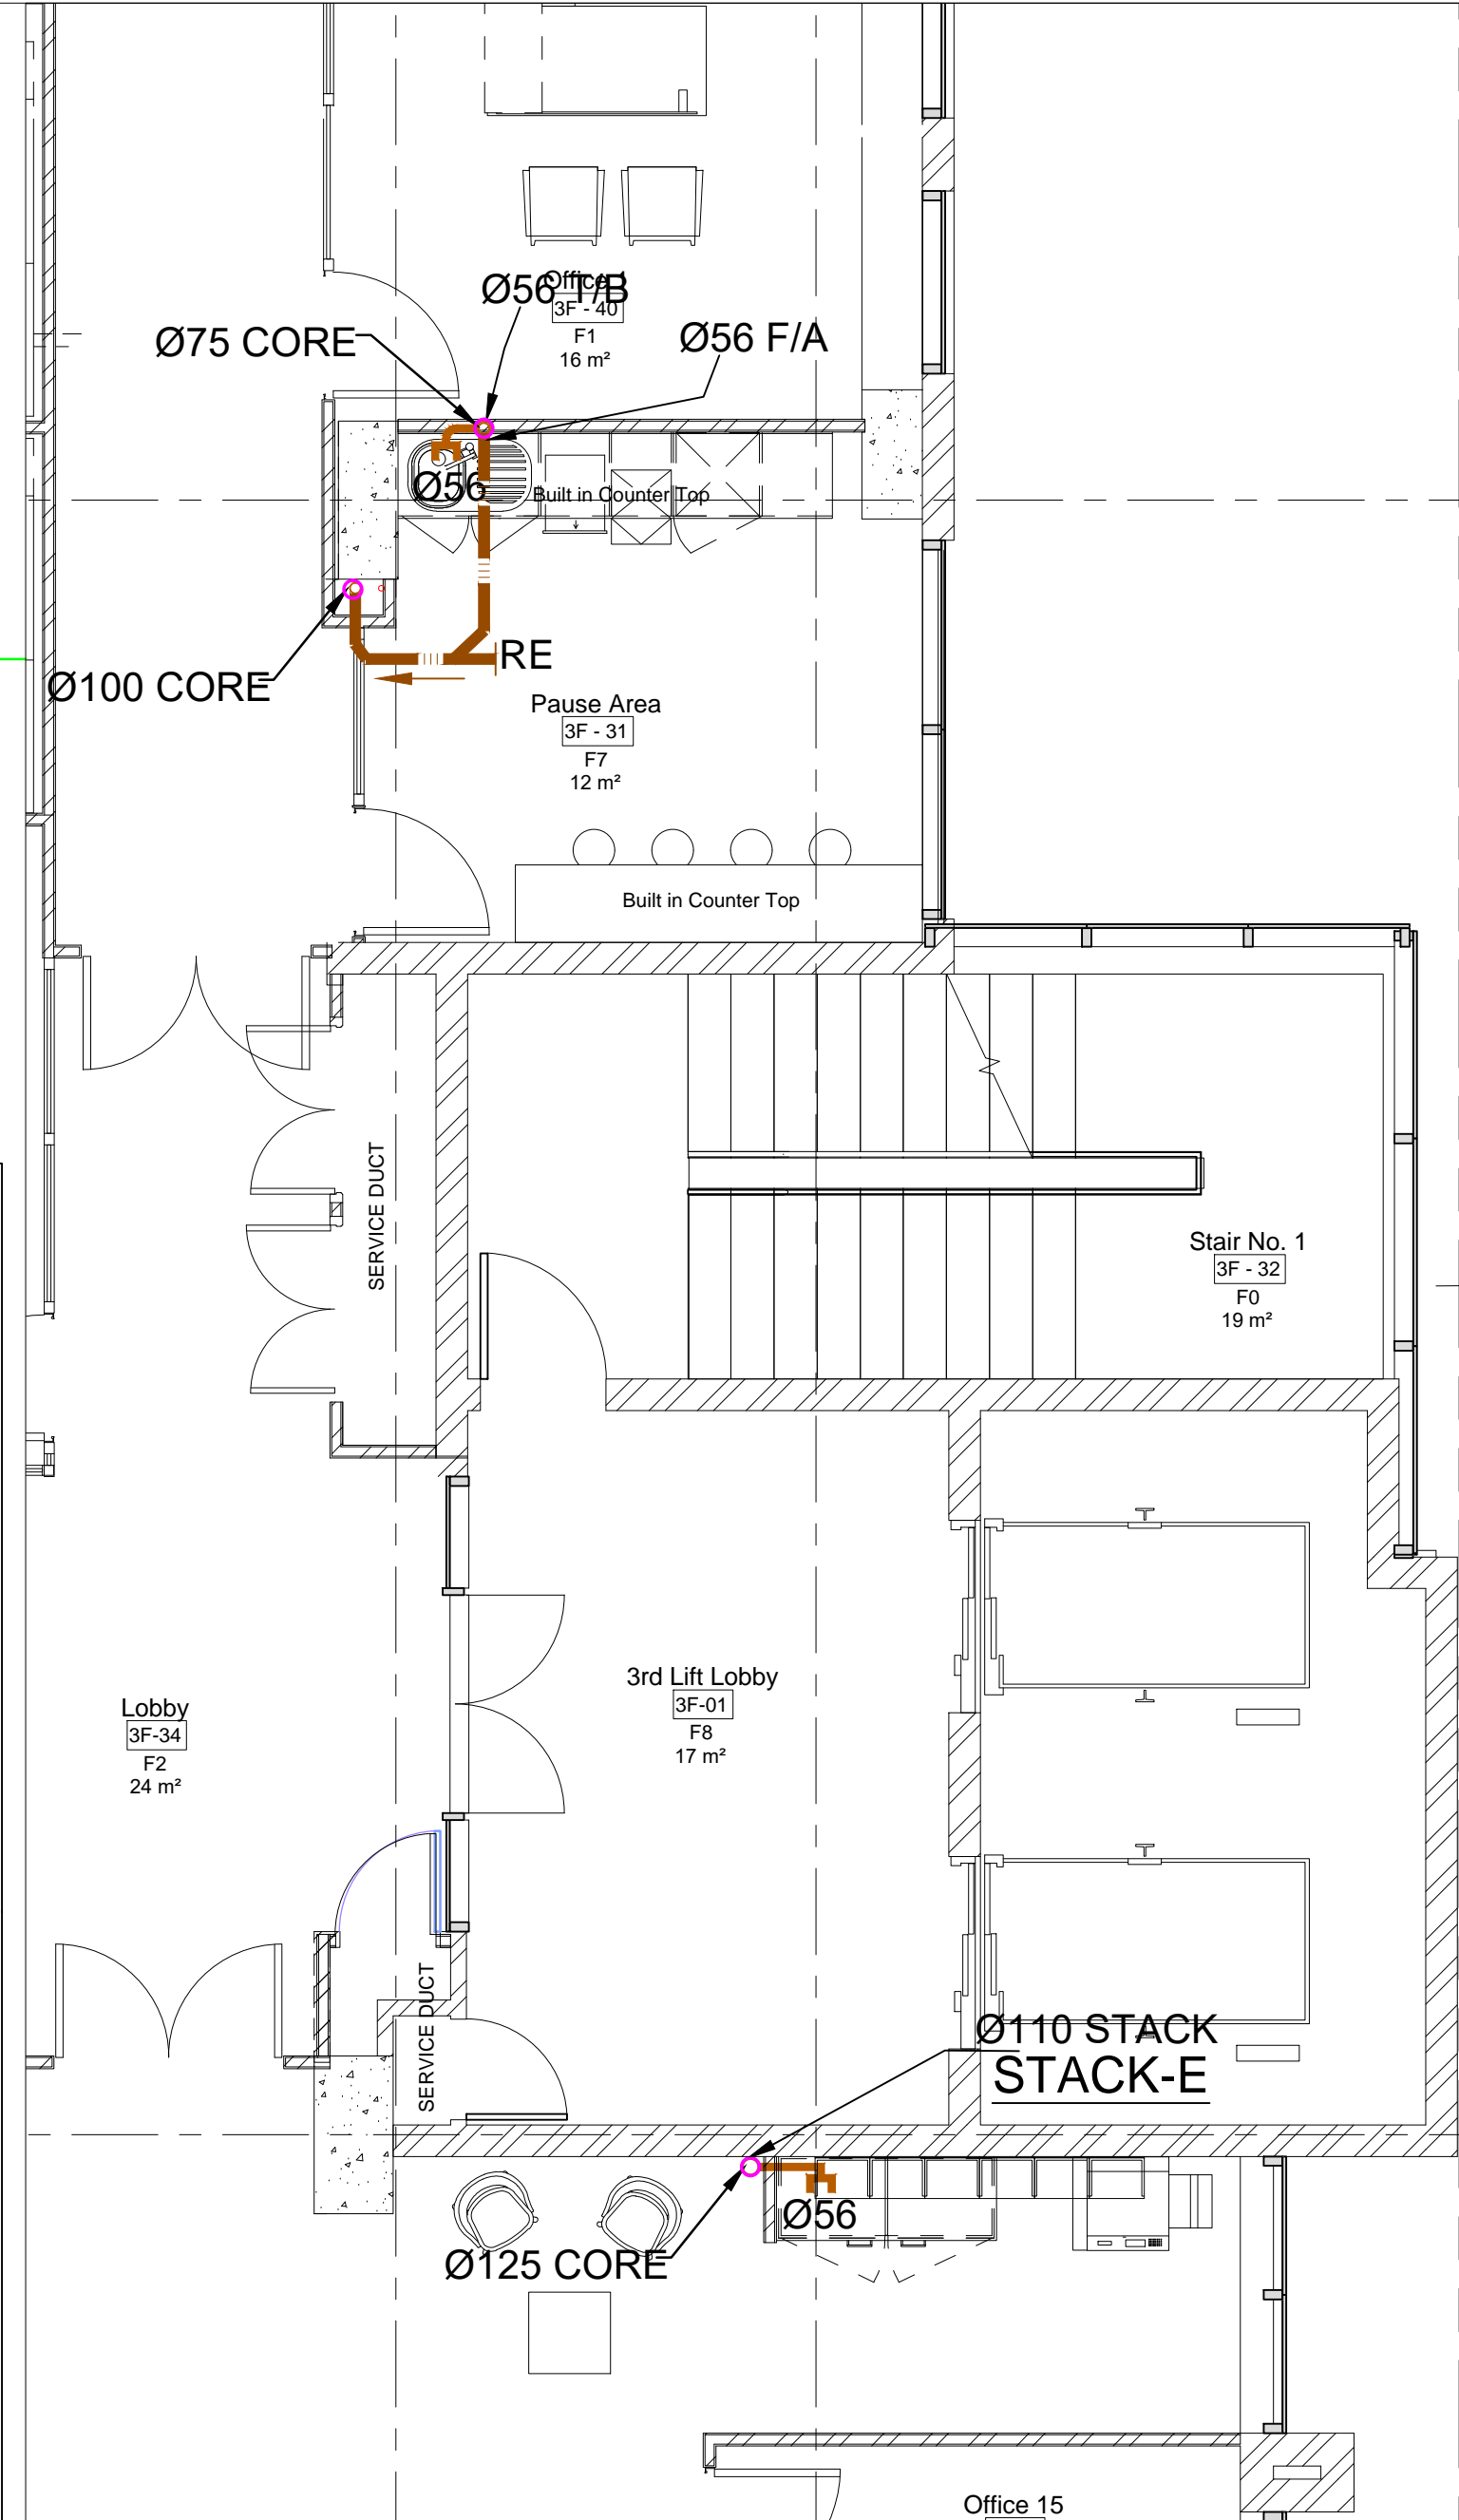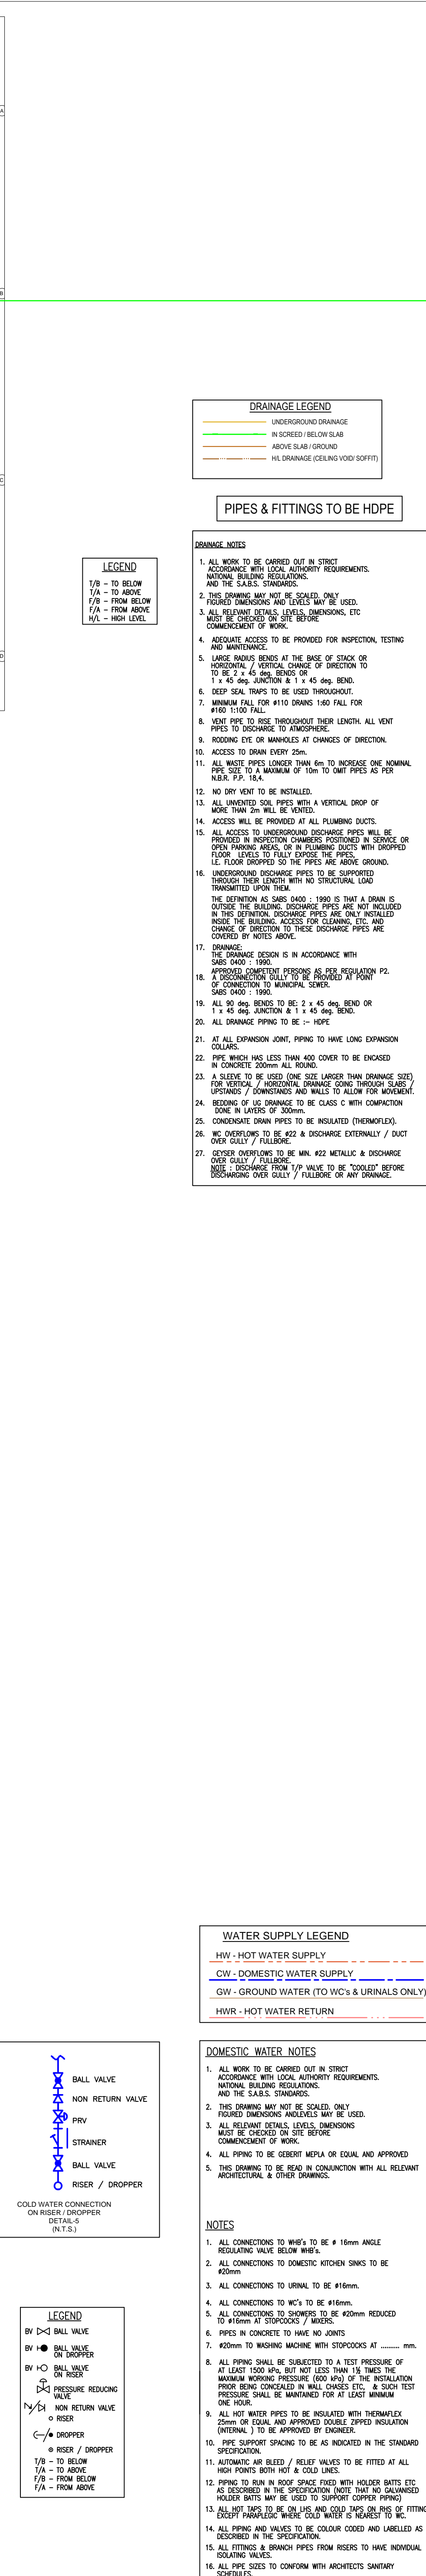

Floor 3 Drainage Part Layout
1 : 50

GENERAL NOTES:

All boundaries, dimensions and levels are to be checked on site before construction and any discrepancies are to be reported to the Architect.

Partial Service: Any discrepancies with site or other information is to be advised to the Architect and direction or approval is to be sought before the implementation of the detail.

Do not scale this drawing.

For the purpose of coordination, all relevant parties must check this information prior to implementation and report any discrepancies to the Architect.

FOR TENDER

REVISIONS

NO.	DATE	DESCRIPTION	REV BY:

© COPYRIGHT. THIS DRAWING MAY NOT BE REPRODUCED OR TRANSMITTED IN ANY FORM OR BY ANY MEANS, IN PART OR IN WHOLE WITHOUT THE PERMISSION OF THE DESIGNER.

ALL WORK TO BE CARRIED OUT IN ACCORDANCE WITH SANS CODES 1040, 1041 & LOCAL AUTHORITY REGULATIONS.

USE FIGURED DIMENSIONS ONLY - DO NOT SCALE. ANY CONSTRUCTION FROM THESE DRAWINGS IS AT OWNER'S RISK.

ALL BOUNDARIES, DIMENSIONS AND LEVELS ARE TO BE CHECKED ON SITE BEFORE CONSTRUCTION AND ANY DISCREPANCIES ARE TO BE REPORTED TO THE ARCHITECT.

PARTIAL SERVICE: ANY DISCREPANCIES WITH SITE OR OTHER INFORMATION IS TO BE ADVISED TO THE ARCHITECT AND DIRECTION OR APPROVAL IS TO BE SOUGHT BEFORE IMPLEMENTATION OF THE DRAWING.

FOR THE PURPOSE OF COORDINATION, ALL RELEVANT PARTIES MUST CHECK THIS INFORMATION PRIOR TO IMPLEMENTATION AND REPORT ANY DISCREPANCIES TO THE ARCHITECT.

Mechanical Engineer : Ganny Govender
Signature: _____ Date: _____

LDM
Solutions For The Built Environment

PTA Office: 239 Lange Street, Moss Maboneng Street, Brooklyn, Pretoria 0182
• Tel: (+27) 12 346 8876

Client: Government Printing Works
Signature: _____ Date: _____

PROJECT:
ERF 3265, Pretoria Central, Government Printing Works
ADDRESS:
378 Schubart St, Pretoria Central, Pretoria, 0002, RSA.

DRAWING TITLE:
FLOOR 3 PLUMBING AND DRAINAGE LAYOUT

BUILDING CLASSIFICATION	CLIMATE ZONE
G1	2

Paper Size	SCALE	1 : 50
A0		

Drawn	Checked	DATE	REVISION
LM	GG	11/12/2017	

PROJECT No.	DRAWING No.	REVISION
GP/17-006	P-4004	T0