



BLOCK H ABLUTIONS LIGHTING LAYOUT  
SCALE 1:100

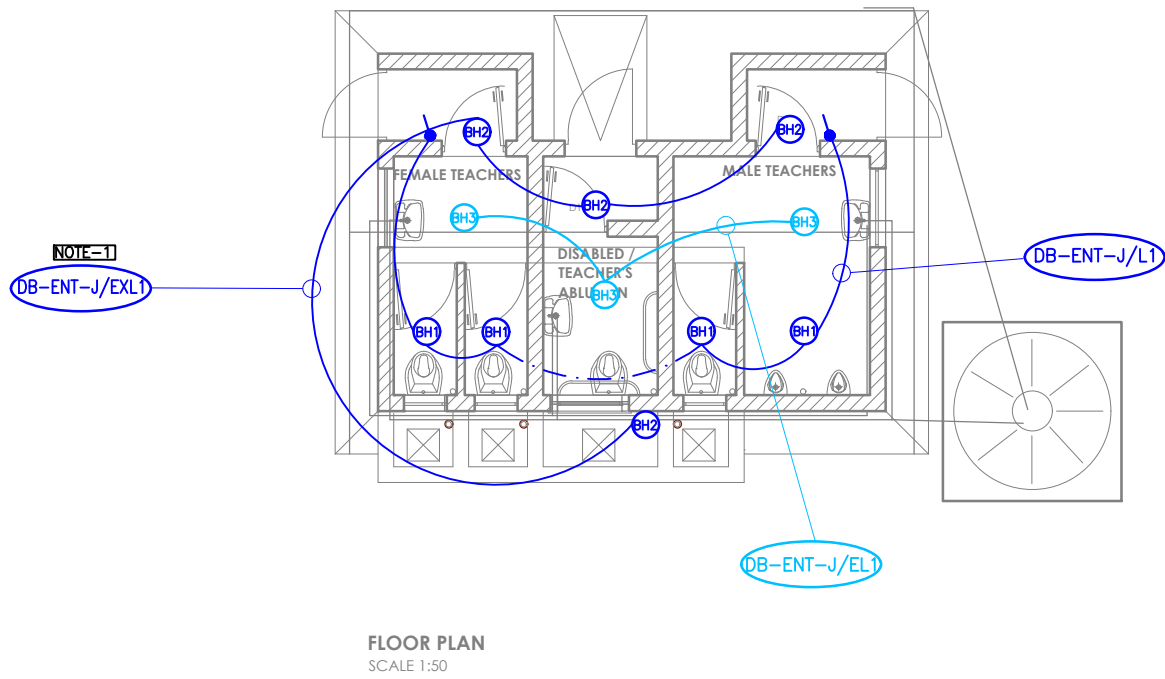

BLOCK J STAFF ABLUTIONS LIGHTING LAYOUT  
SCALE 1:100

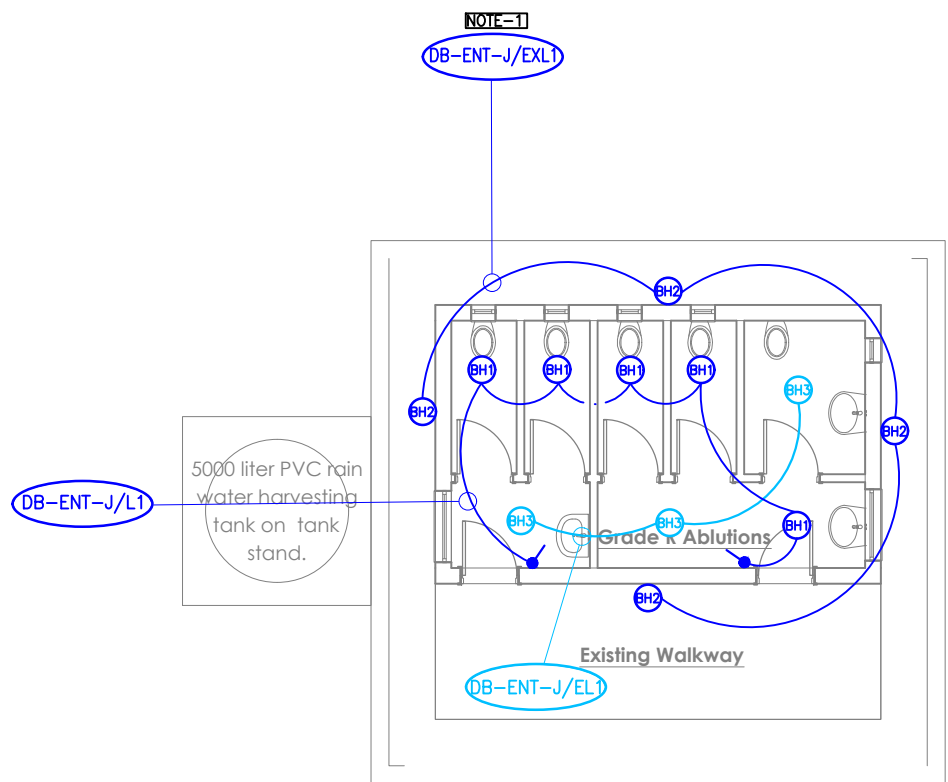

BLOCK J GRADE R ABLUTIONS LIGHTING LAYOUT  
SCALE 1:100

LIGHTING LEGEND	
B	DN-ANT 1240, 4400lm, LED, COOL WHITE – SUPPLIED BY AURORA OR EQUAL & APPROVED
BE	AS 'T' BUT WITH 20% MAINTAINED BATTERY PACK. A SEPARATE NON-SWITCHED LINE FEED FROM OUT-GOING SIZE OF MCB TO EMERGENCY FITTING IS TO BE INSTALLED. 24HR
EN	EN-BH15, 1150lm, LED, COOL WHITE – SUPPLIED BY AURORA OR EQUAL & APPROVED
EN	EN-BH120, 1650lm, COOL WHITE – AURORA LIGHTING OR EQUAL AND APPROVED
✓	LIGHT SWITCH

LIGHTING NOTES:

NOTE 1 :CONTROL OF LIGHTING:  
EXTERNAL LIGHTING CONTROL TO BE ON A DAY/NIGHT SWITCH.

NOTE 2 :24 HOUR LIGHTING:  
24 HOUR LIGHTING NOT TO BE SWITCHED THROUGH CONTRACTOR. FITTING MARKED 'E' TO HAVE 20% MAINTAINED BATTERY PACK FITTED ONLY FOR MINIMUM OF 1hr.

NOTE 3 :STEEL TRUNKING:  
STEEL TRUNKING OF SUITABLE SIZE COMPLETE WITH PVC COVER AND ACCESSORIES FOR LIGHTING AND POWER CIRCUITS. WIRING IN TRUNKING NOT TO EXCEED 400V CAPACITY.5 AMP SOCKETS TO BE MOUNTED IN TRUNKING OR ON TRUNKING FOR PLUGGING IN OF LUMINAIRES.

B	24.03.2023	T.T	ISSUED FOR INFORMATION	LL	LL
A	15.02.2023	T.T	ISSUED FOR INFORMATION	LL	LL
REV	DATE	BY	DESCRIPTION	CHK	APD

DRAWING STATUS:

FOR INFORMATION

FUNDER:



Department  
Education  
PROVINCE OF KWAZULU-NATAL

IMPLEMENTING AGENT:



Development Bank  
of Southern Africa

PRINCIPAL AGENT:



No.7 Bush Strike Close  
Victoria County Club Estate  
170 Peltier Brown Drive  
Montrose,Pietermaritzburg  
3201  
Tel :033 347 7900  
cell:montsburg@mariswe.com

ARCHITECT:



KAB ARCHITECTS  
14013 Blocksway Road  
JHB 2196  
TEL:011 834 4102  
FAX:011 834 4102  
CELL:083 31 108  
www.kabarchitects.co.za

ENGINEER:



6, Scherwitz Road | Bera | East London  
Tel: +27 43 722 3353 Fax: +27 86 554 6496  
info@karosolutions.co.za

PROJECT:

ENTUMENI PRIMARY SCHOOL,  
ESHOWE LOCAL AUTHORITY,  
uMLALAZI, 3830, KWAZULU-NATAL.  
EMIS No:500138602

TITLE:

BLOCK H & J ABLUTIONS  
LIGHTING LAYOUT

SCALE @ A1:	1:100	CHECKED:	LL	APPROVED:	LL
CAD FILE:	KS130-L03	DESIGN/DRAWN:	T.T-T.T	DATE:	15.02.2023
PROJECT No:	KS130	DRAWING No:	KS130-L03	REV:	B

© COPYRIGHT RESERVED  
The content of this document is privileged and confidential and may not be disclosed or reproduced without the express authorisation of the author, being "KARO SOLUTIONS"