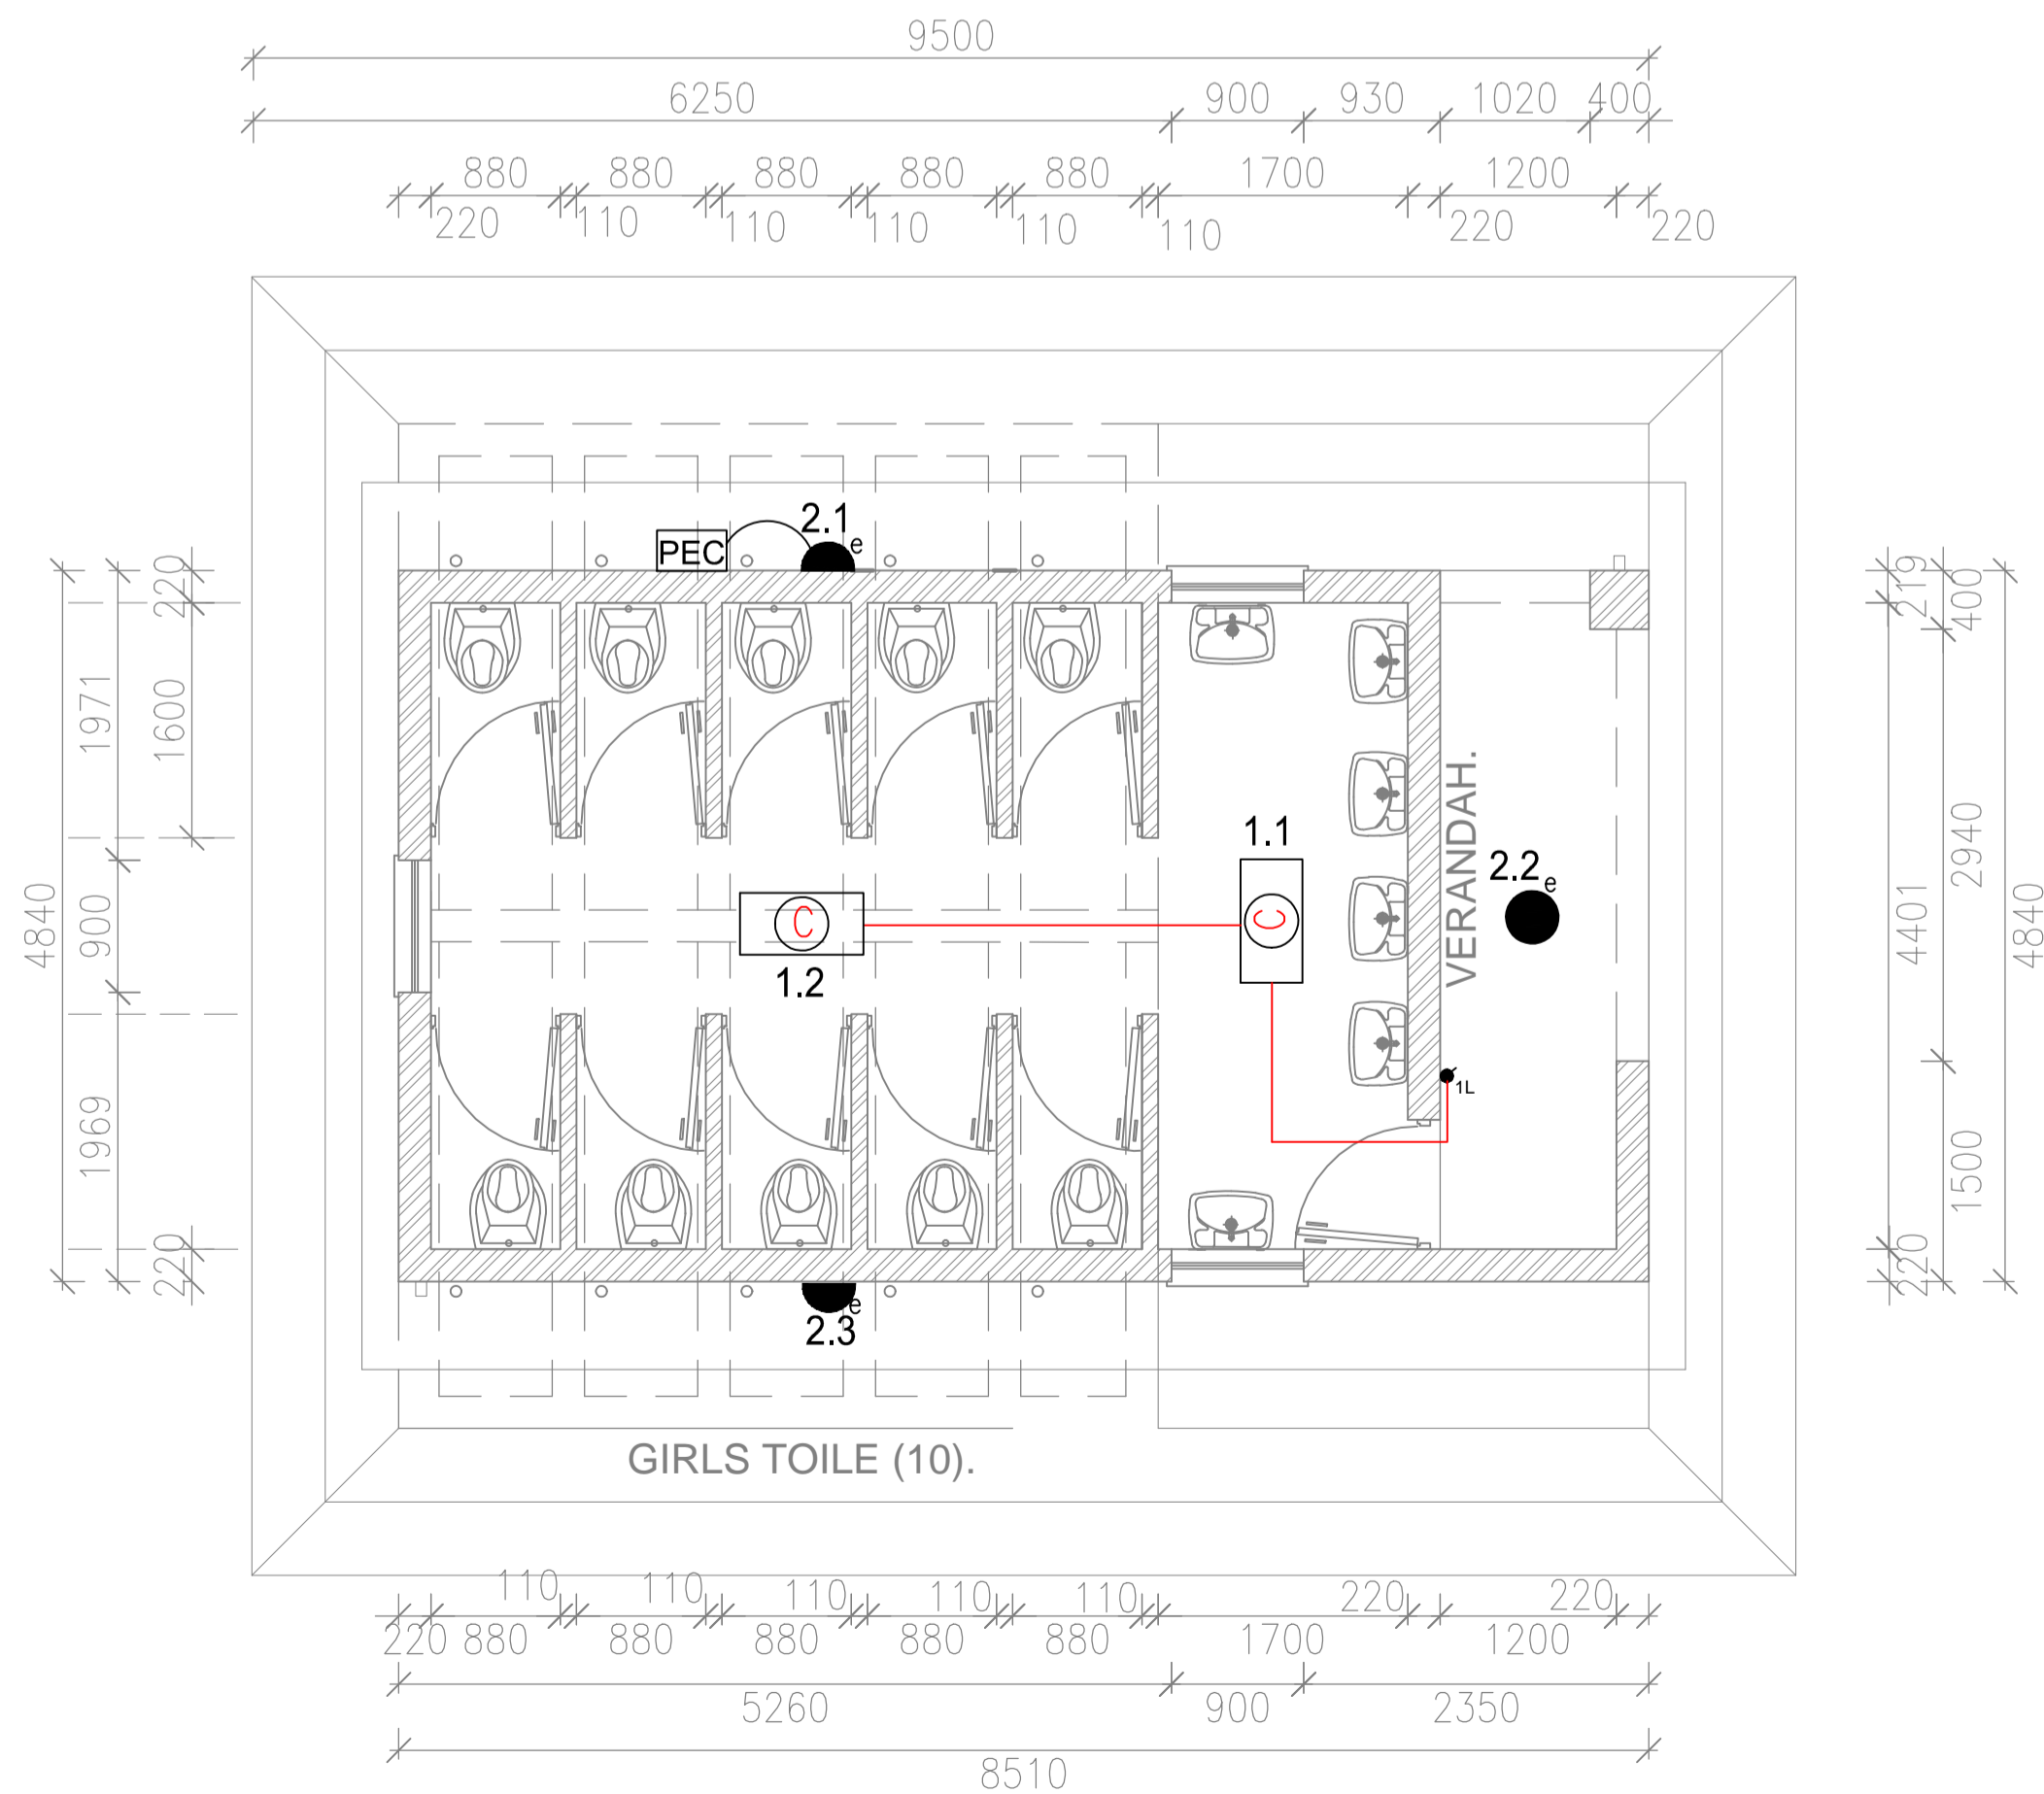

 

 

 



 
 





 

 



 
 




EDUCATOR'S TOILET BLOCK



GIRLS TOILET BLOCK

ELECTRICAL LEGEND	
	LED 6 W, 4000K, RECESSED FLAT PANEL DOWNLIGHT LUMINAIRE WITH WHITE TRIM.
	1500 mm, 2x24W, T8 LED OPEN CHANNEL.
	1200 mm, 1x18W, T8 LED OPEN CHANNEL.
	ROUND 20W LED, 6500K BULKHEAD LUMINAIRE WITH BLACK TRIM AS IN BEKA 31126 or OTHER APPROVED.
	PHOTO ELECTRIC CELL.
	LIGHT SWITCH.
	2 WAY LIGHT SWITCH.
	WATERTIGHT LIGHT SWITCH.
	TELEPHONE OUTLET.
	COMPUTER DATA OUTLET.
	SCHOOL SIREN PUSH BUTTON @ UNDERCOUNTER HEIGHT.
	ALARM MOTION SENSOR.
	ALARM CONTROL BOX.
	SINGLE 16A SS - EURO SOCKET COMBO.
	DUO SOCKET OUTLET.
	THREE PHASE ISOLATOR.
	SINGLE PHASE ISOLATOR.
	DB BOARD.
	INTERCOM OUTLET.
	1200 mm, 2 x 18W, T8 LED SURFACE LUMINAIRE WITH LBR DIFFUSER.
	1200 mm, 2 x 18W, T8 LED VAPOUR PROOF FITTING.
	LOUD SPEAKER FOR PA SYSTEM.
	MICROPHONE FOR PA SYSTEM.
	AMPLIFIER FOR PA SYSTEM.
	ALARM KEY PAD.
	ALARM BELL.

NOTES:

1.0 ALL POWER SKIRTING TO BE MOUNTED AT FINISHED FLOOR LEVEL UNLESS OTHERWISE STATED.

2.0 ALL OTHER 16 A SWITCHED SOCKETS OUTLETS TO BE MOUNTED AT 300 mm AFFL.


3.0 ALL EXTERIOR LIGHTING TO BE MOUNTED AT A 2200 MM HEIGHT AFFL.

REV	DATE	DESCRIPTION	DR	CK
0	28.08.2022	FOR TENDER PURPOSES ONLY	PBM	TM

CLIENT:

  
Department: Education  
PROVINCE OF KWAZULU-NATAL  
Head Office, 247 Burger Street, Pietermaritzburg, 3200  
Telephone Number: +27 11 313 3611  
Fax number: (033) 362 1203

IMPLEMENTING AGENT:

  
DEVELOPMENT BANK OF SOUTHERN AFRICA  
Building Africa's Prosperity  
Headway Hill, 1258 Lever Road, Midrand, South Africa  
Telephone Number: +27 11 313 3611  
Fax number: +27 11 313 3500 or +27 11 313 3297  
Web: webmaster@dbsa.org

PROFESSIONAL SERVICE PROVIDER:

  
Rogus Westway, 3 Floor, 18 The Boulevard  
Westway Office Park, Westville, DURBAN  
Tel: (031) 003 3137, Fax: (031) 003 3101, FZE, 086 671 3682  
shu@bhadama.co.za

ARCHITECT:

  
PROJECTS  
ARCHITECTS | PROJECT MANAGERS

PROJECT:

EZAKHELENI HIGH SCHOOL

SERVICE:

ELECTRICAL

  
Engineers, Planners and Project Managers  
37 LESLEY DRIVE  
HATTON ESTATE  
PINETOWN,  
3610  
TEL : 083-362 4784  
FAX : 086-635 1149  
e-mail address :  
trm@ngolela.co.za

DRAWING TITLE

ABLUTION BLOCKS  
LIGHTING LAYOUT

DESIGNED: T.N. MAPHUMULO		APPROVED: T.N. MAPHUMULO	
SIGNATURE:		SIGNATURE:	
DRAWN: PBM	DRAWING NUMBER		REV.
DATE: 31.8.2022	2210-EL,EP-04		0
SCALE: 1:50			