


ELECTRICAL LEGEND:

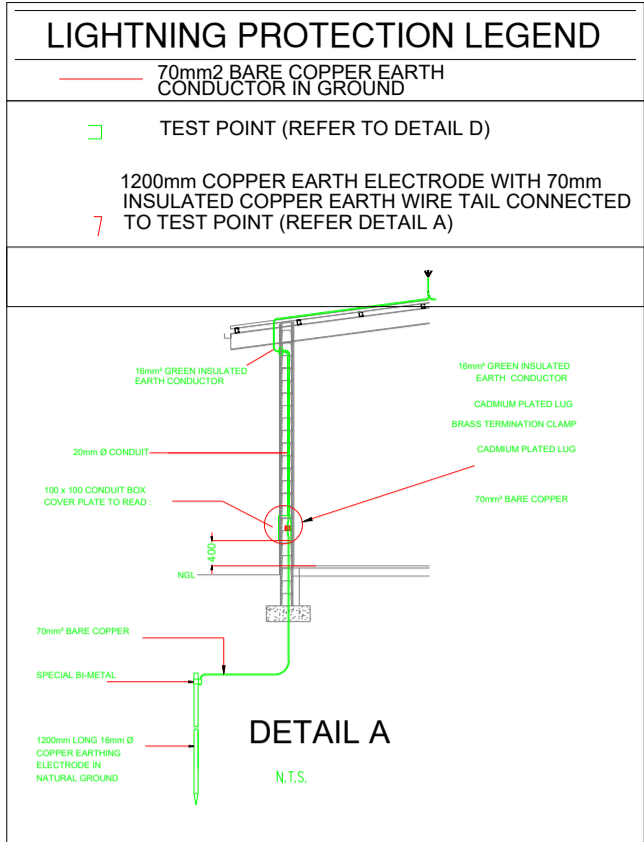

Signature by the Client department

Development Bank of Southern Africa
Headway Hill 1258 Lever Road,
Midrand South Africa
P O Box 1234
Halfway House 1685
Tel: +27 11 313 3911
Email: webmaster@dbsa.org



| Revisions | | | |
|-----------|------|-------------|---------|
| Rev. No | Date | Description | Rev. by |
| | | | |
| | | | |

CHECKED BY CONSULTANT
NAME

SIGNATURE Date
CONSULTANT
Deedscon Consult (Pty) Ltd
52 Panorama Road
Rooihuskraal
Centurion
0157
Tel: +27 12 655 0994
Email: info@deedscon.co.za




PROVINCE OF KWAZULU NATAL
DEPARTMENT
OF
EDUCATION
HEAD: EDUCATION

PROJECT DEPARTMENT OF EDUCATION:
KING CETSHWAYO DISTRICT MUNICIPALITY
PROPOSAL - UPGRADES & ADDITIONS
NDABAYAKHE PRIMARY SCHOOL

DRAWING DESCRIPTION
FIVE CLASS ROOM BLOCK
EARTHING & LIGHTNING
PROTECTION

| PROJECT No. | | DRAWING No. | REVISION |
|-------------|----------|----------------|----------|
| 1905-04 | | EE-EL-02 | 0 |
| SCALE | DATE | DESIGNED/DRAWN | CHECKED |
| N.T.S | Sep 2022 | T.M | A.M |

NDABAYAKHE PRIMARY SCHOOL

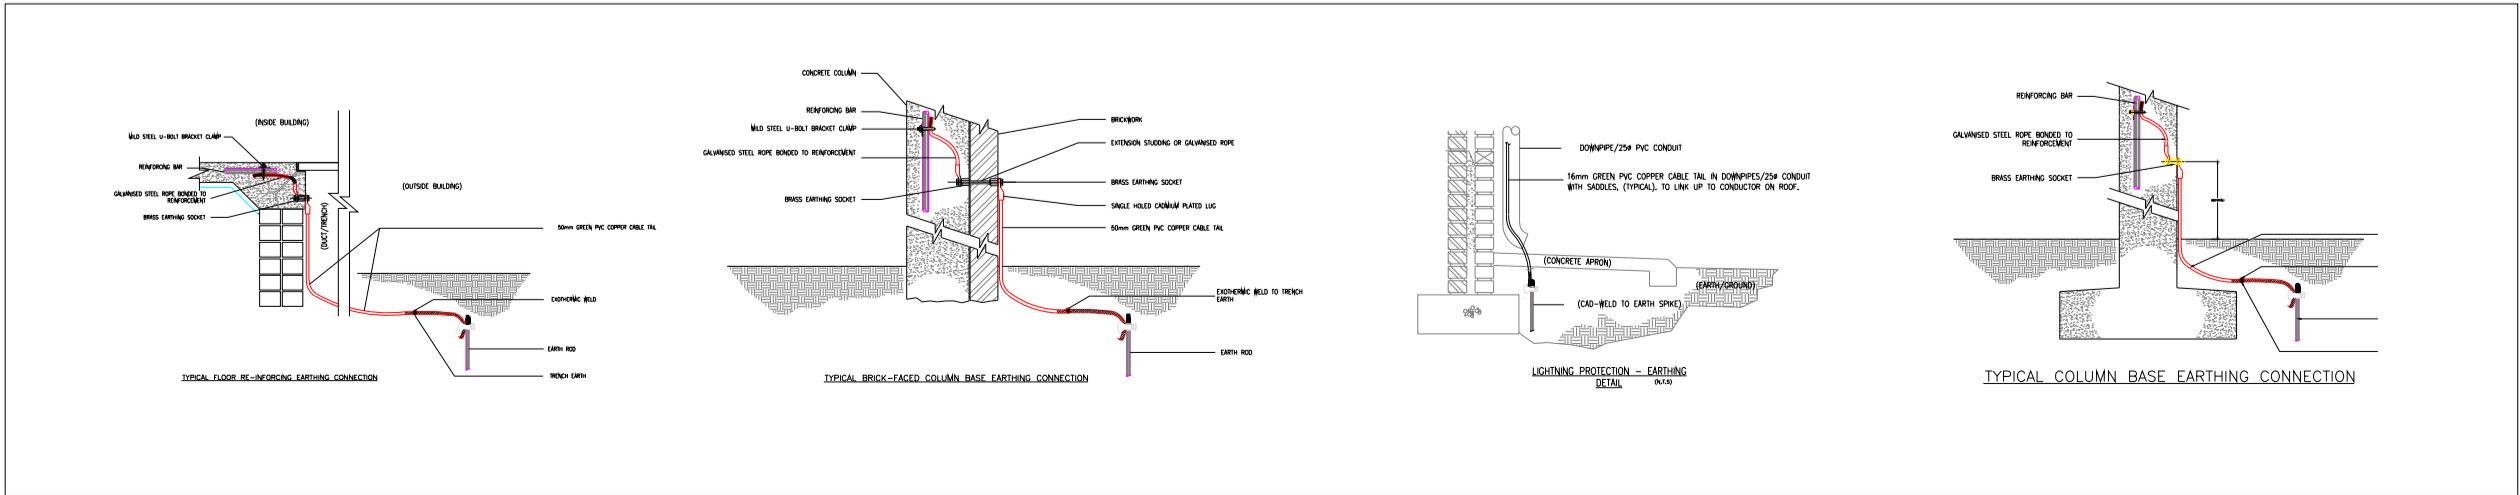

- Electrical Notes
1. ALL CONDUIT RECESSED SABS APPROVED PVC WITH GALVANISED OUTLET BOXES (EXCEPT 50 DIA ROUND TO BE PVC).
 2. HEIGHTS ABOVE FINISHED FLOOR LEVEL SHOWN TO BOTTOM OF OUTLETS/EQUIPMENTS.
 3. ALL EQUIPMENT TO BE SUPPLIED AS SPECIFIED. NO ALTERNATIVES TO BE TENDERED.
 4. ALL LIGHT SWITCHES MOUNTED AT 1400mm AFFL UNLESS OTHERWISE SPECIFIED.
 5. ALL OUTLETS, WIRING AND CONDUITS TO BE INSTALLED BY ELECTRICAL CONTRACTOR.
 6. SOCKET OUTLETS MOUNTED AT 300mm AFFL UNLESS OTHERWISE SPECIFIED.
 7. THIS DRAWING TO BE READ IN CONJUNCTION WITH ALL OTHER RELATED DRAWINGS FOR CO-ORDINATION PURPOSES.