








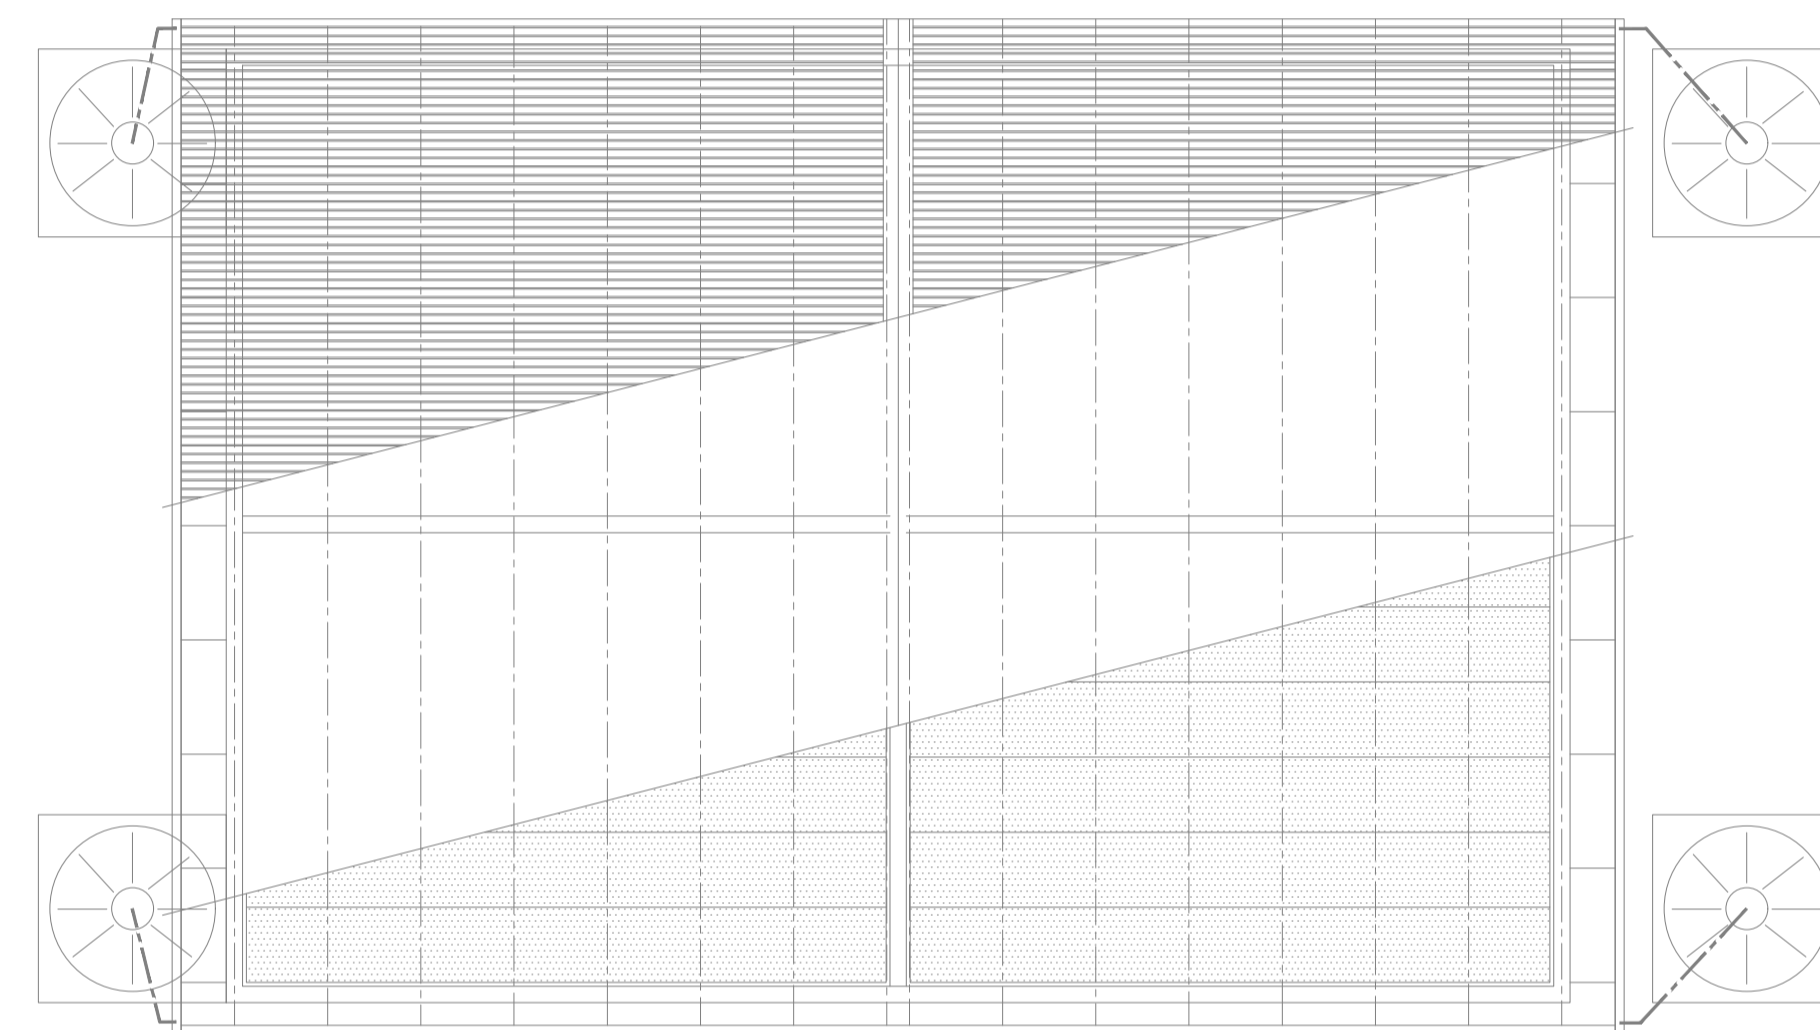

 
## BLOCK B Lighting layout



## BLOCK B Power layout

- ## GENERAL NOTES
1. The installation is to comply in full to the latest SANS 10142 standards and specifications.
  2. All SSO must be installed in accordance with new gazetted regulations and in accordance to SANS 0142 and Department of Education regulations and specifications.
  3. The electrical installation shall be in accordance to the standards and regulations prescribed by SANS for the installation of electrical services.
  4. All electrical equipment to be SABS approved.
  5. It is the responsibility of the installation contractor to ensure all and every aspect of the electrical installation is in accordance to required standards and regulations prescribed by South African standards for the wiring of premises and in accordance to the Department of Education, Province of KwaZulu Natal specifications and regulations.
  6. Each sub distribution board and Telkom distribution tray to be earthed.

LEGEND	
	1500mm OPEN CHANNEL FLUORESCENT FITTING EQUAL TO LASCOR RITA, FITTED WITH 2x OSRAM STRAU-EM 22.5W/B40 1500mm 3600 LUMENS
	LIGHT SWITCH
	ROUND LED BULKHEAD WITH DIE-CAST ALUMINIUM BASE [WHITE] AND OPAL HIGH IMPACT ACRYLIC DIFFUSER, EQUAL TO BEKA 30 SERIES BULKHEAD PWLED 1470 LUMENS - WALL MOUNTED.
	16A 3-PIN & NEW IKA, EURO
	SINGLE PHASE ISOLATOR
	DISTRIBUTION BOARD
	DAY/NIGHT SENSOR

-	ISSUED FOR TENDER:							14.09.2022	
REVISIONS									
CLIENT									
<div><p>Development Bank of Southern Africa</p></div>									
PROJECT									
NCEKUYA PRIMARY SCHOOL EMIS 500342213 KING CETHSWAYO DISTRICT UMLALAZI LOCAL MUNICIPALITY									
DESCRIPTION									
BLOCK B ELECTRIC SERVICES									
STATUS		INFORMATION				CONSTRUCTION			
		TENDER			X	AS BUILT			
DRAWING NO		SCALE	PAGE SIZE	DRAWN	Home & Summary Registered as: Crag Wood Registration number: ECCA Registration No: 09000406			APPROVED BY	REV
2110_03		AS SHOWN	A1	CD					-



**E-CONSULTING**  
Business Electronic and Energy management services

UNIT 8 WOODLANDS HOUSE  
17A WOODLANDS ROAD  
WOODSTOCK, 8801  
TEL 021 447 3832  
email: [csn@econsulting.co.za](mailto:csn@econsulting.co.za)