


BLOCK A : ADMINISTRATION & 2 x CLASSROOM BLOCK

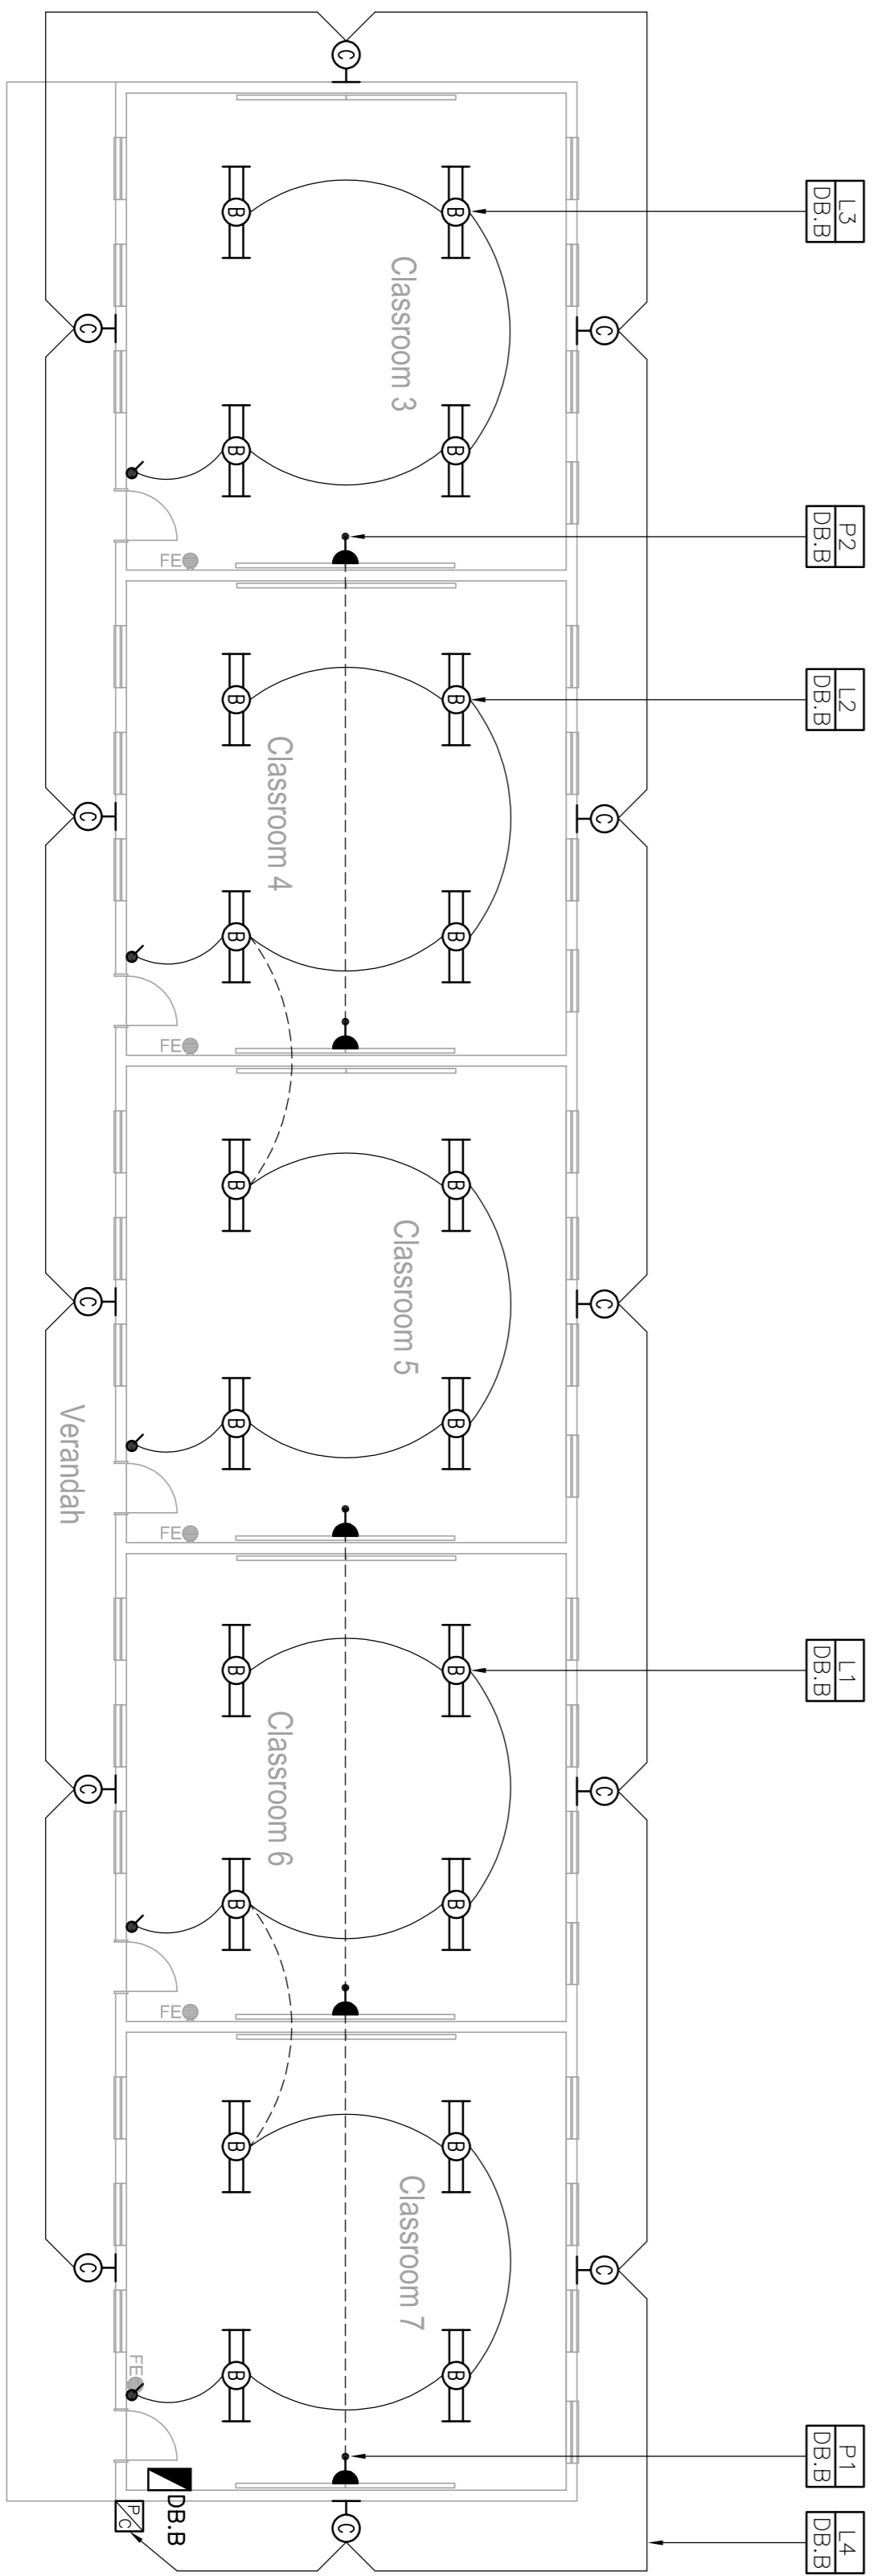

BLOCK B : 5 x CLASSROOM BLOCK

LEGEND	
SYMBOL	DESCRIPTION
	SURFACE MOUNTED OPEN CHANNEL SINGLE TUBE FLUORESCENT LUMINAIRE COMPLETE WITH LAMP & ELECTRONIC CONTROL GEAR TO SWANLITE LUM/ATL/SUP/259/ECG OR SIMILAR APPROVED.
	SURFACE MOUNTED OPEN CHANNEL FLUORESCENT LUMINAIRE COMPLETE WITH LAMP & ELECTRONIC CONTROL GEAR, AS SWANLITE LUM/ATL/SUP/25/5AB5.
	ROUND BULKHEAD LUMINAIRES COMPLETE WITH LAMPS & CONTROL GEAR TO SWANLITE LUM/AA/PLK/2PL18.
	SURFACE MOUNTED BULKHEAD SIMILAR OR EQUAL TO BEKA 20 SERIES 15W LED WITH BLACK TRIM RING.
	SURFACE MOUNTED, IP65 VAPOUR PROOF FLUORESCENT LUMINAIRE COMPLETE WITH 2x28W LAMPS & ELECTRONIC CONTROL GEAR, TO SWANLITE OR SIMILAR APPROVED.
	PHOTO CELL – DAYLIGHT SWITCH
	ONE LEVER TWO WAY LIGHT SWITCH
	ONE LEVER ONE WAY LIGHT SWITCH
	16A SINGLE SOCKET OUTLET WITH WHITE COVER PLATE + EURO TYPE.
	16A SINGLE DEDICATED SOCKET OUTLET WITH RED COVER PLATE
	16A DOUBLE SOCKET OUTLET WITH WHITE COVER PLATE
	DOUBLE POLE, SURFACE MOUNTED ISOLATOR
	DATA POINT
	TELEPHONE OUTLET POINT
	INTERCOM OUTLET POINT
	BELL/SIREN
	2 COMPARTMENT POWER SKIRTING
	MAIN DISTRIBUTION BOARD (INTERCOM)
	TELECOMMUNICATION DISTRIBUTION BOARD
	ELECTRICAL DISTRIBUTION BOARD
	INTERCOM DISTRIBUTION BOARD
	EARTHING OR LIGHTNING PROTECTION IN THE ROOF
	INTRUDER ALARM

Notes

FOR APPROVAL

STATUS ENGINEERS retains the copyright in all intellectual property including designs and/or documents prepared in terms of this appointment for the project covered by this appointment which shall remain the design and/or copyright of STATUS ENGINEERS. The design and/or documents shall be subject to payment for the design being received. Use for any other purpose constitutes an infringement of copyright, and all rights are reserved.

REQUIRED DEPARTMENT SIGNATURES

PROJECT MANAGER: _____

ARCHITECT: _____

REGIONAL MANAGER: _____

REVISIONS:

Rev no.	Date:	Description:	Rev by

Signed by Consultant (Partner/Director)

Signature _____ Date _____

Client:

ISiNiC

ENGINEERS

QUALITY YOU CAN TRUST

P.O.Box 2484

Newcastle 2340

Tel: (034) 312 5767

Fax: (034) 312 9879

e-mail: newcastle@sinicengineers.co.za

D&SA

DEVELOPMENT BANK OF SOUTHERN AFRICA

Building Africa's Prosperity

Project title:

KWABULAWAYO HIGH SCHOOL

Drawing description:

FLOOR PLANS BLOCK A & B LIGHTING & SMALL POWER LAYOUT

Designed by:

F.NEL

Drawn by:

D.SINGH

Checked:

Scale/s:

1:100

Date:

10 September 2022

Consultant Drawing number:

300238-20-L-E02

Revision:

A0