
 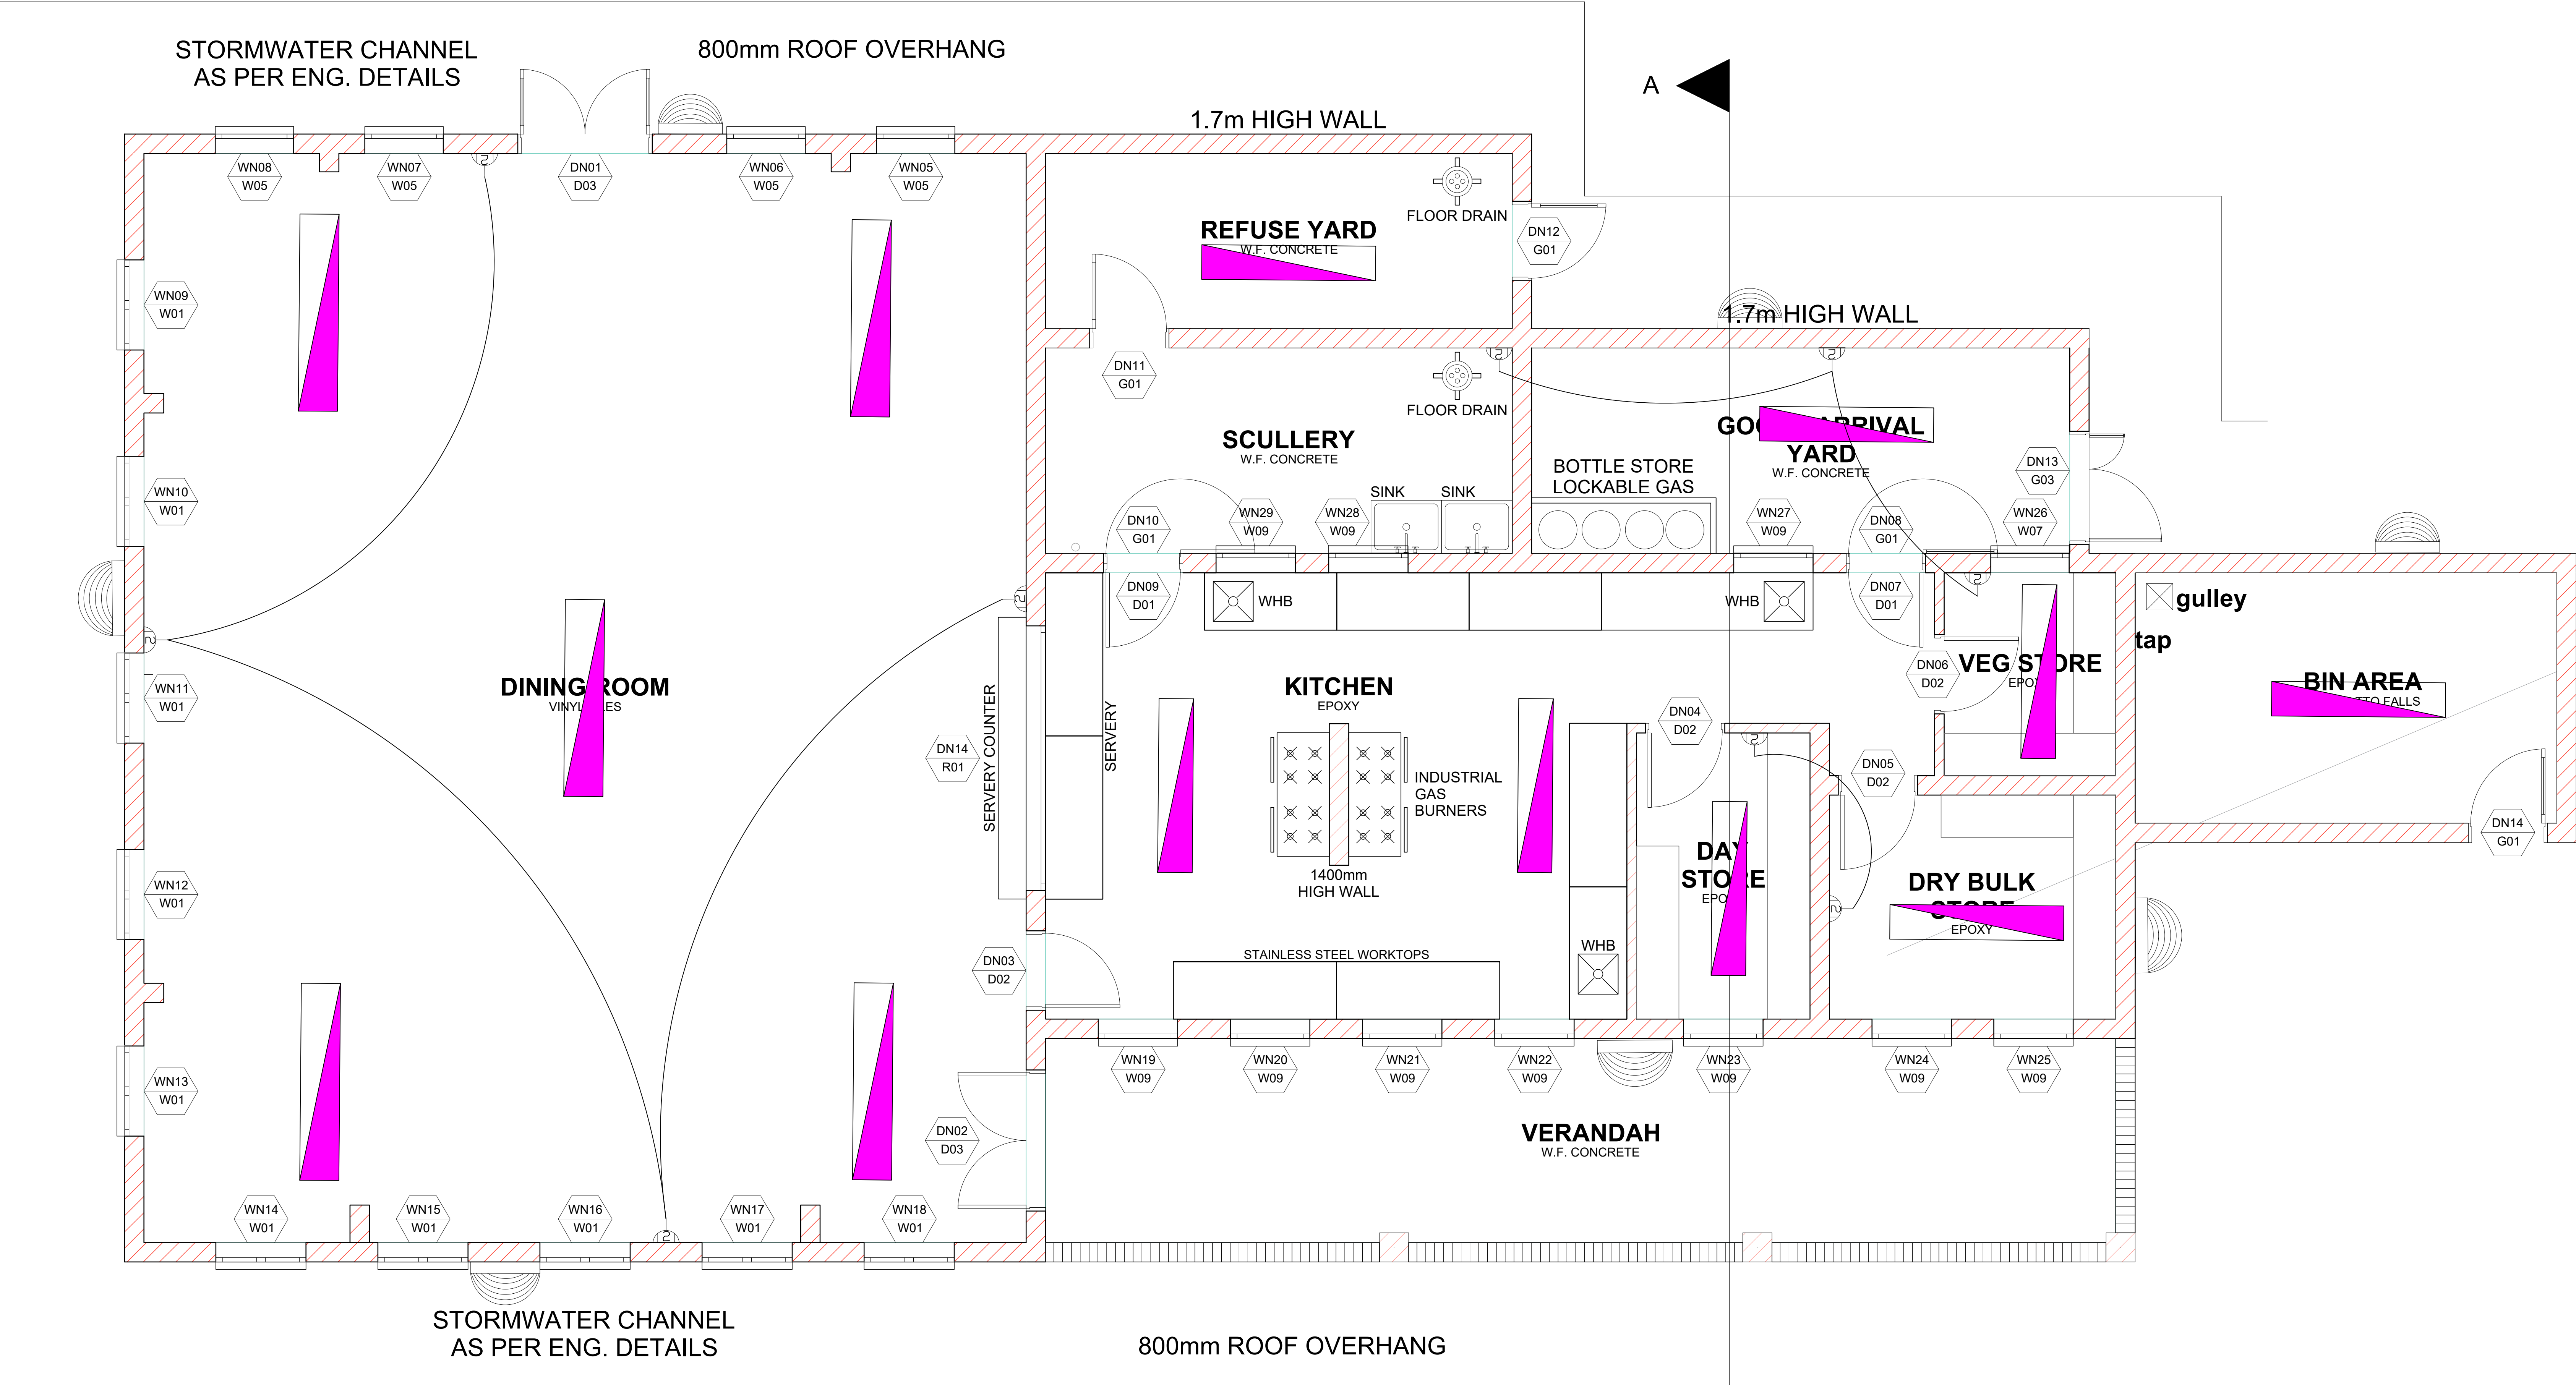


 


GROUND FLOOR PLAN
SCALE - 1:100

LEGEND

FLUORESCENT LIGHT 58W

DOUBLE POLE WALL SOCKET

ODIN 4000K
EXTERNAL SURFACE MOUNTED

NOTES

DRAWING MUST BE REFERENCED AGAINST ALL OTHER RELATED DRAWINGS, ARCHITECTURAL, MECHANICAL, CIVIL, STRUCTURAL, ETC.

DRAWING MUST BE REFERENCED AGAINST ALL SPECIFICATIONS

ALL EQUIPMENT POSITIONING TO BE FINALIZED ON SITE

ALL EQUIVALENT EQUIPMENT SHALL BE APPROVED BY THE ENGINEER

No.	REVISION	DATE	ZONE	BY

CLIENT:




education
Department of
Education
FREE STATE PROVINCE

SIGN OFF REGISTER

Organisation	Name	Signature	Date

CONSULTANT:

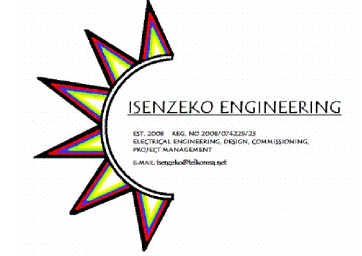

TELEFAX : 031 562 0291
E-MAIL : isenzeko@telkomso.net

DISCIPLINE

ELECTRICAL

ELECTRICAL
ENGINEER'S
SIGNATURE:

SERVICE

POPANO SECONDARY SCHOOL

DRAWING TITLE

INTERNAL, EXTERNAL LIGHTING & SMALL
POWER NUTRITION BLOCK

SCALE	DRAWN	DATE	CHECKED
NTS	S.N	FEB 2026	V.H

BUILDING ELECTRICAL LIGHTING AND SMALL POWER	DRAWING No. PSS-NB-EL-SP-00
--	------------------------------------