




SECTION 01
SCALE 1:200
(SEE DWG. REG. NO. 9368-501)

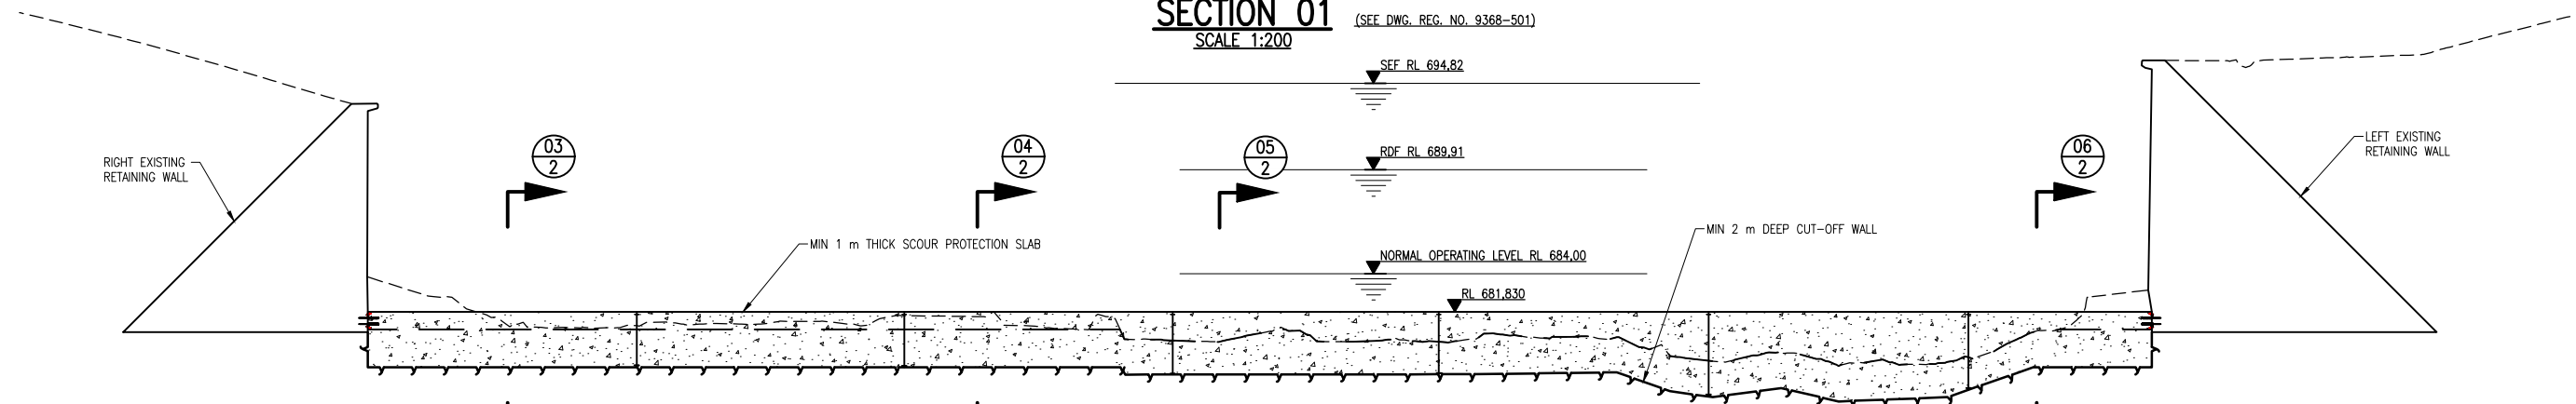


SECTION 02
SCALE 1:200
(SEE DWG. REG. NO. 9368-501)

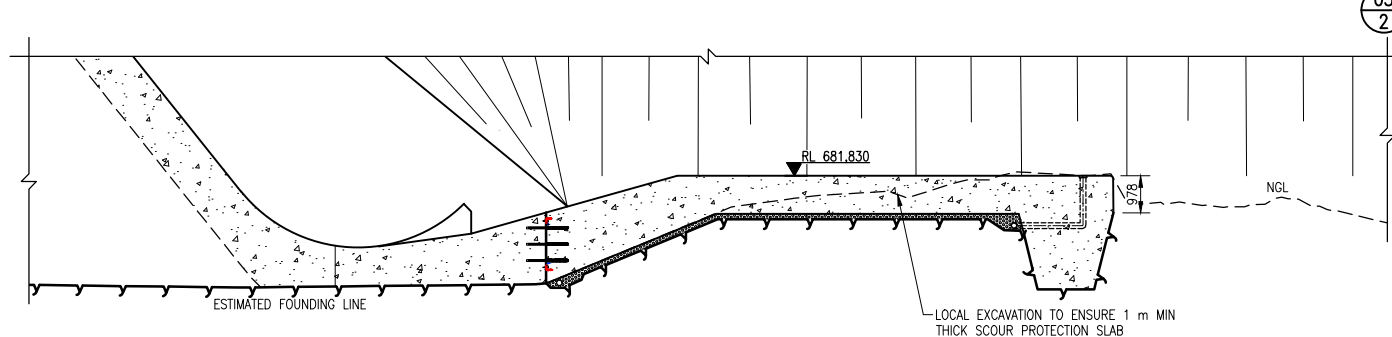


SECTION 03
SCALE 1:100
(SEE DWG. REG. NO. 9368-501)

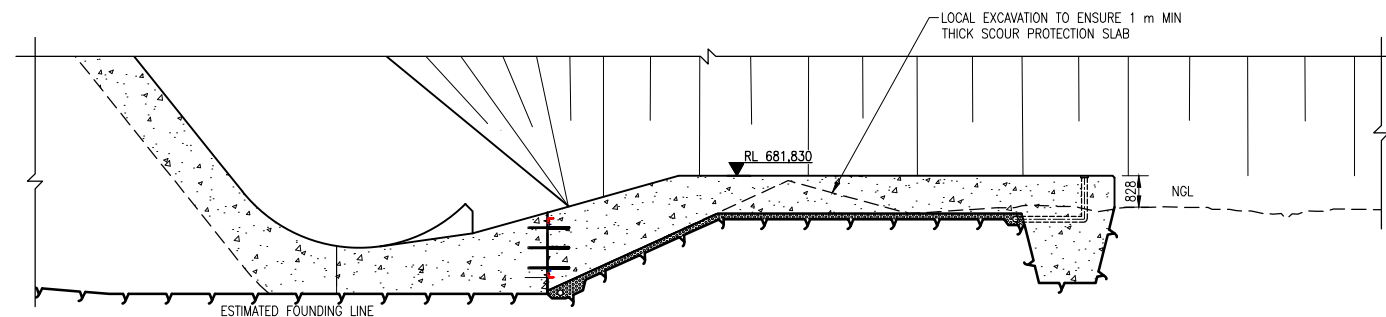

SECTION 04
SCALE 1:100
(SEE DWG. REG. NO. 9368-501)

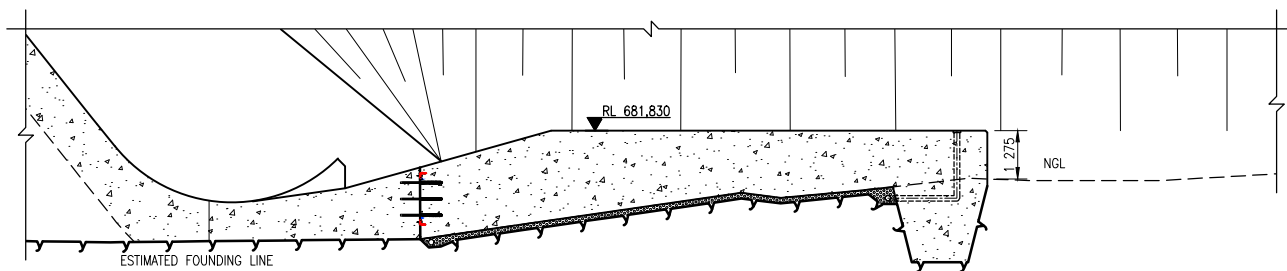

SECTION 05
SCALE 1:100
(SEE DWG. REG. NO. 9368-501)


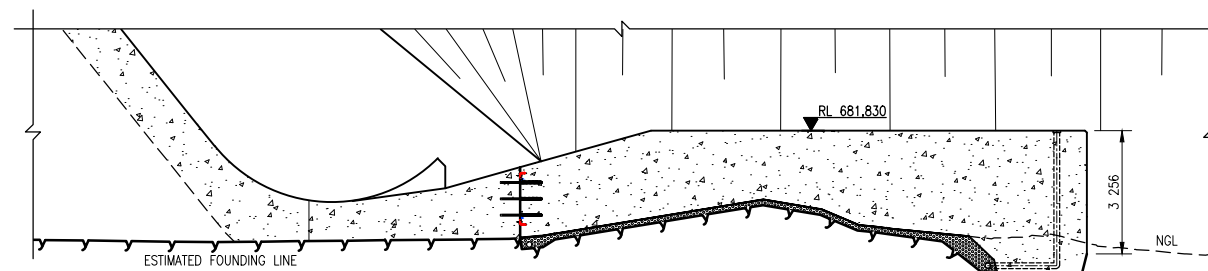


SECTION 06
SCALE 1:100
(SEE DWG. REG. NO. 9368-501)

LIST OF DRAWINGS			
SHEET	DESCRIPTION	OTHER No.	REG. No.
1/6	PLAN LAYOUT AND DETAILS	9368-501	X
3/6	WATERSTOP DETAILS 1	9368-503	X
4/6	WATERSTOP DETAILS 2	9368-504	X
5/6	DRAINAGE LAYOUT AND DETAILS	9368-505	X
6/6	DOWEL PLAN LAYOUT AND DETAILS	9368-501	X
1/1	LIST OF DRAWINGS	9368-015	X

SCALE 1:100

 SCALE 1:200

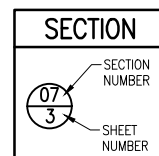

PREPARED BY:		REVISION		FOR	DWS
MOD No.	DATE	DESCRIPTION			
01	06/23	ISSUE FOR CONSTRUCTION	QS		
02	02/24	GENERAL UPDATES	QS		

DEPARTMENT OF WATER AND SANITATION REPUBLIC OF SOUTH AFRICA			
HEAD OFFICE ENGINEERING SERVICES PRIVATE BAG X313 PRETORIA 0001		SEDIBENG BUILDING 185 FRANCIS BAARD STREET PRETORIA (012) 336-7500	
D.M. MASHITSHO DIRECTOR GENERAL		DESIGN: HJ WRIGHT DRAWN: NM	
M BLAESER CHECKED:		DATE:	
HJ WRIGHT ENGINEER:		DATE:	
Q SHAW CHIEF ENGINEER / APP (Pr. Eng):		EXT. APPROVAL / DESIGN CHECKED: DATE:	
DATE:		DIRECTOR (Pr. Eng): DATE:	

GROOT LETABA RIVER WATER DEVELOPMENT PROJECT (GLeWaP)

TZANEEN DAM RAISING
ENERGY DISSIPATION STRUCTURE
SECTIONS AND DETAILS

PROVINCE: LIMPOPO	DISTRICT: TZANEEN	KEYCODES: - - - - -	OTHER NUMBER 9368-502
LOCALITY No.: -	TENDER/ CONTRACT No.: -	SHEET 2 OF 6	REV. X 02